



SECOND FLOOR PLAN

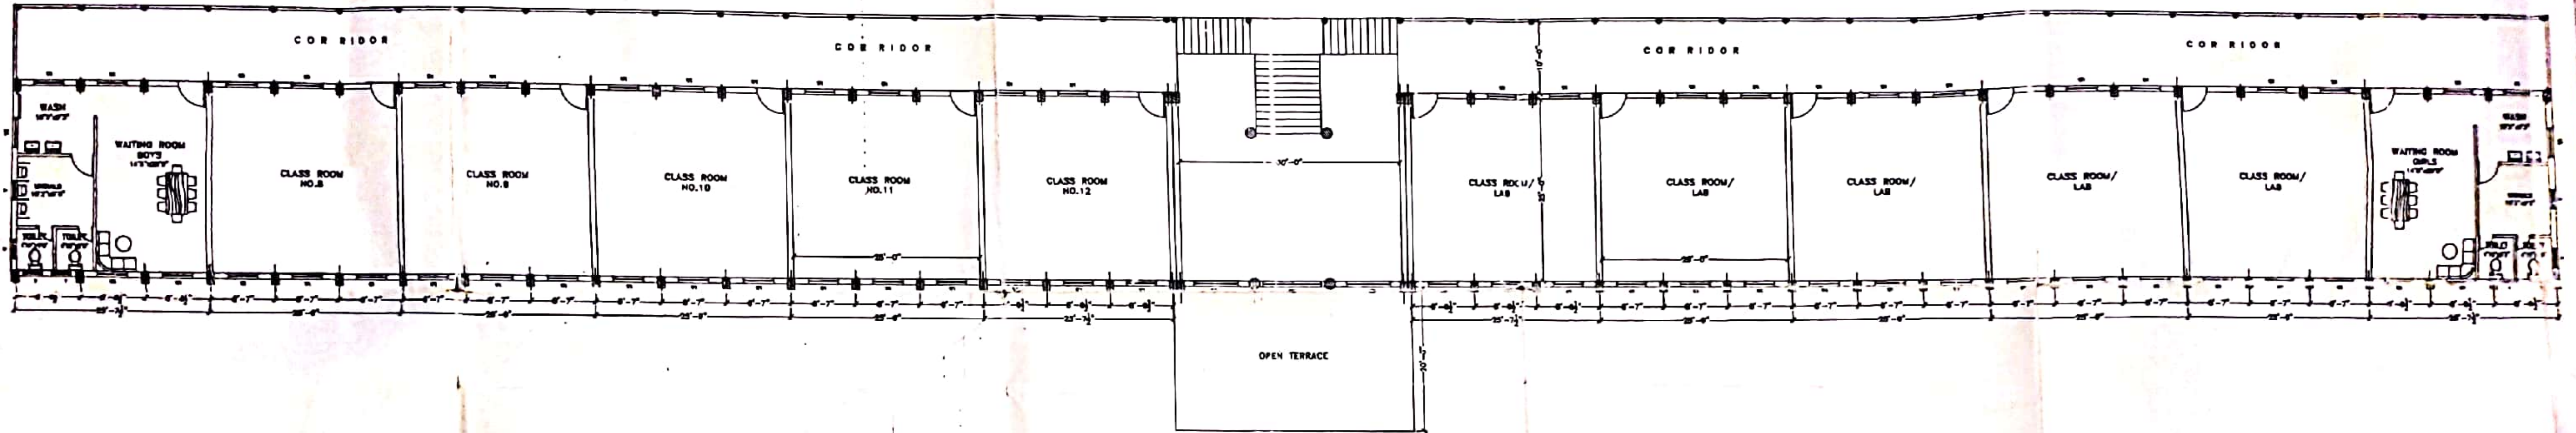

FIRST FLOOR PLAN

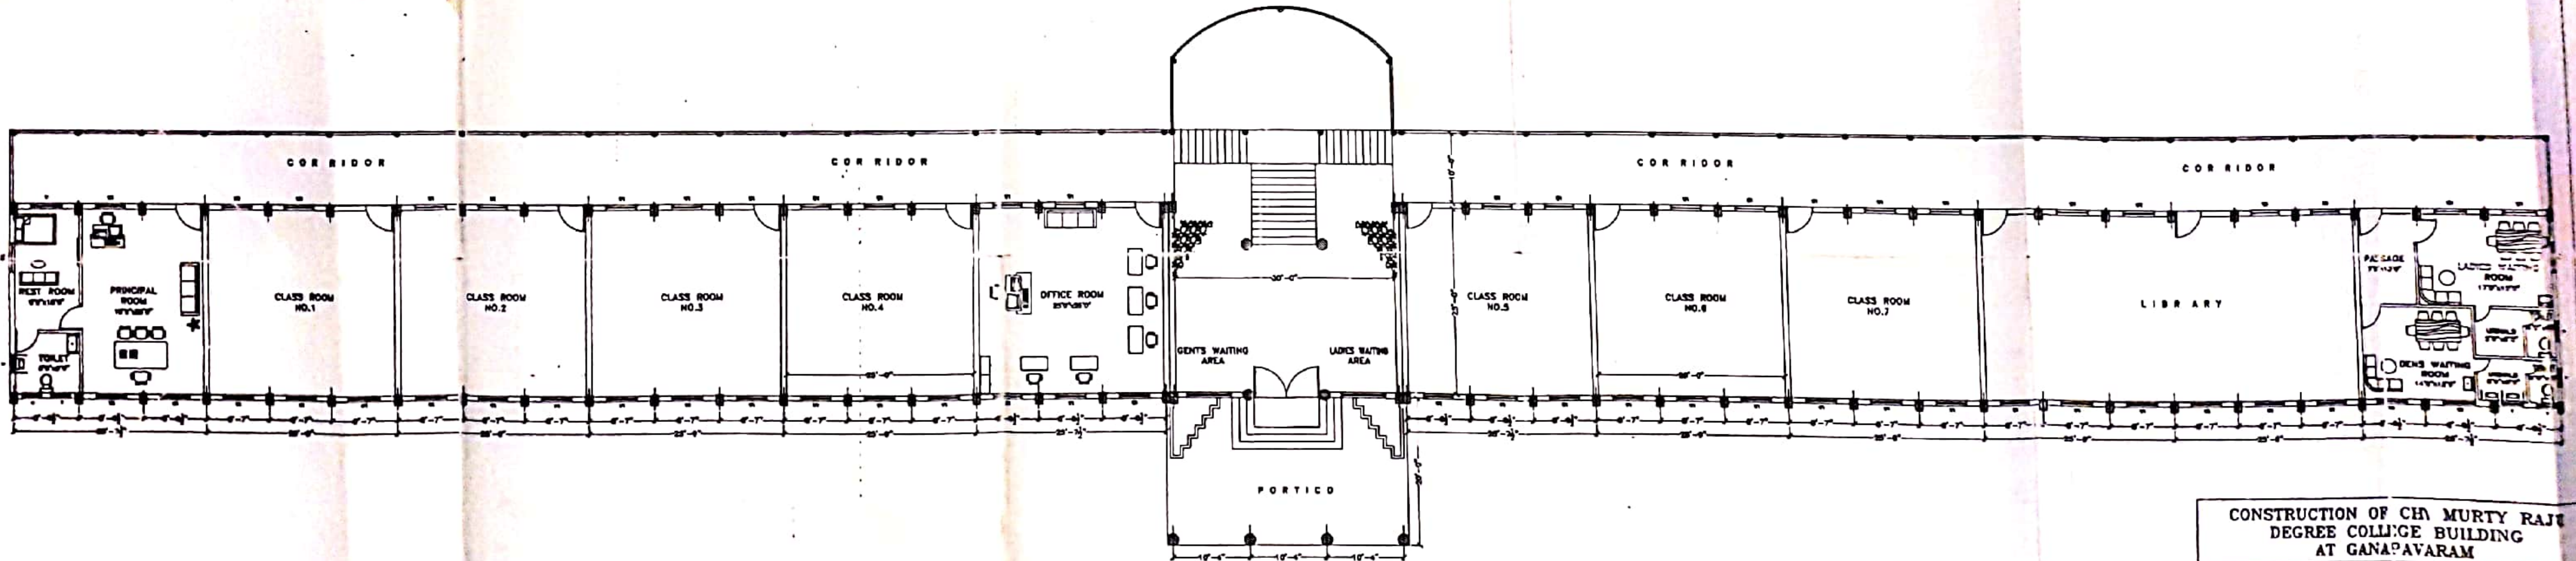

GROUND FLOOR PLAN

CONSTRUCTION OF CH. MURTY RAJ  
DEGREE COLLEGE BUILDING  
AT GANAPAVARAM

CONSULTANTS : P. RAJ & ASSOCIATES  
112, B-3-42/17, DHANAKAPUR COLONY,  
PALLADIYA, HYDERABAD-52.  
PHONE NO : 2321748

SCALE : DATE : 07/01/01 DRG. NO. ARCH/PRJ/GCS/001